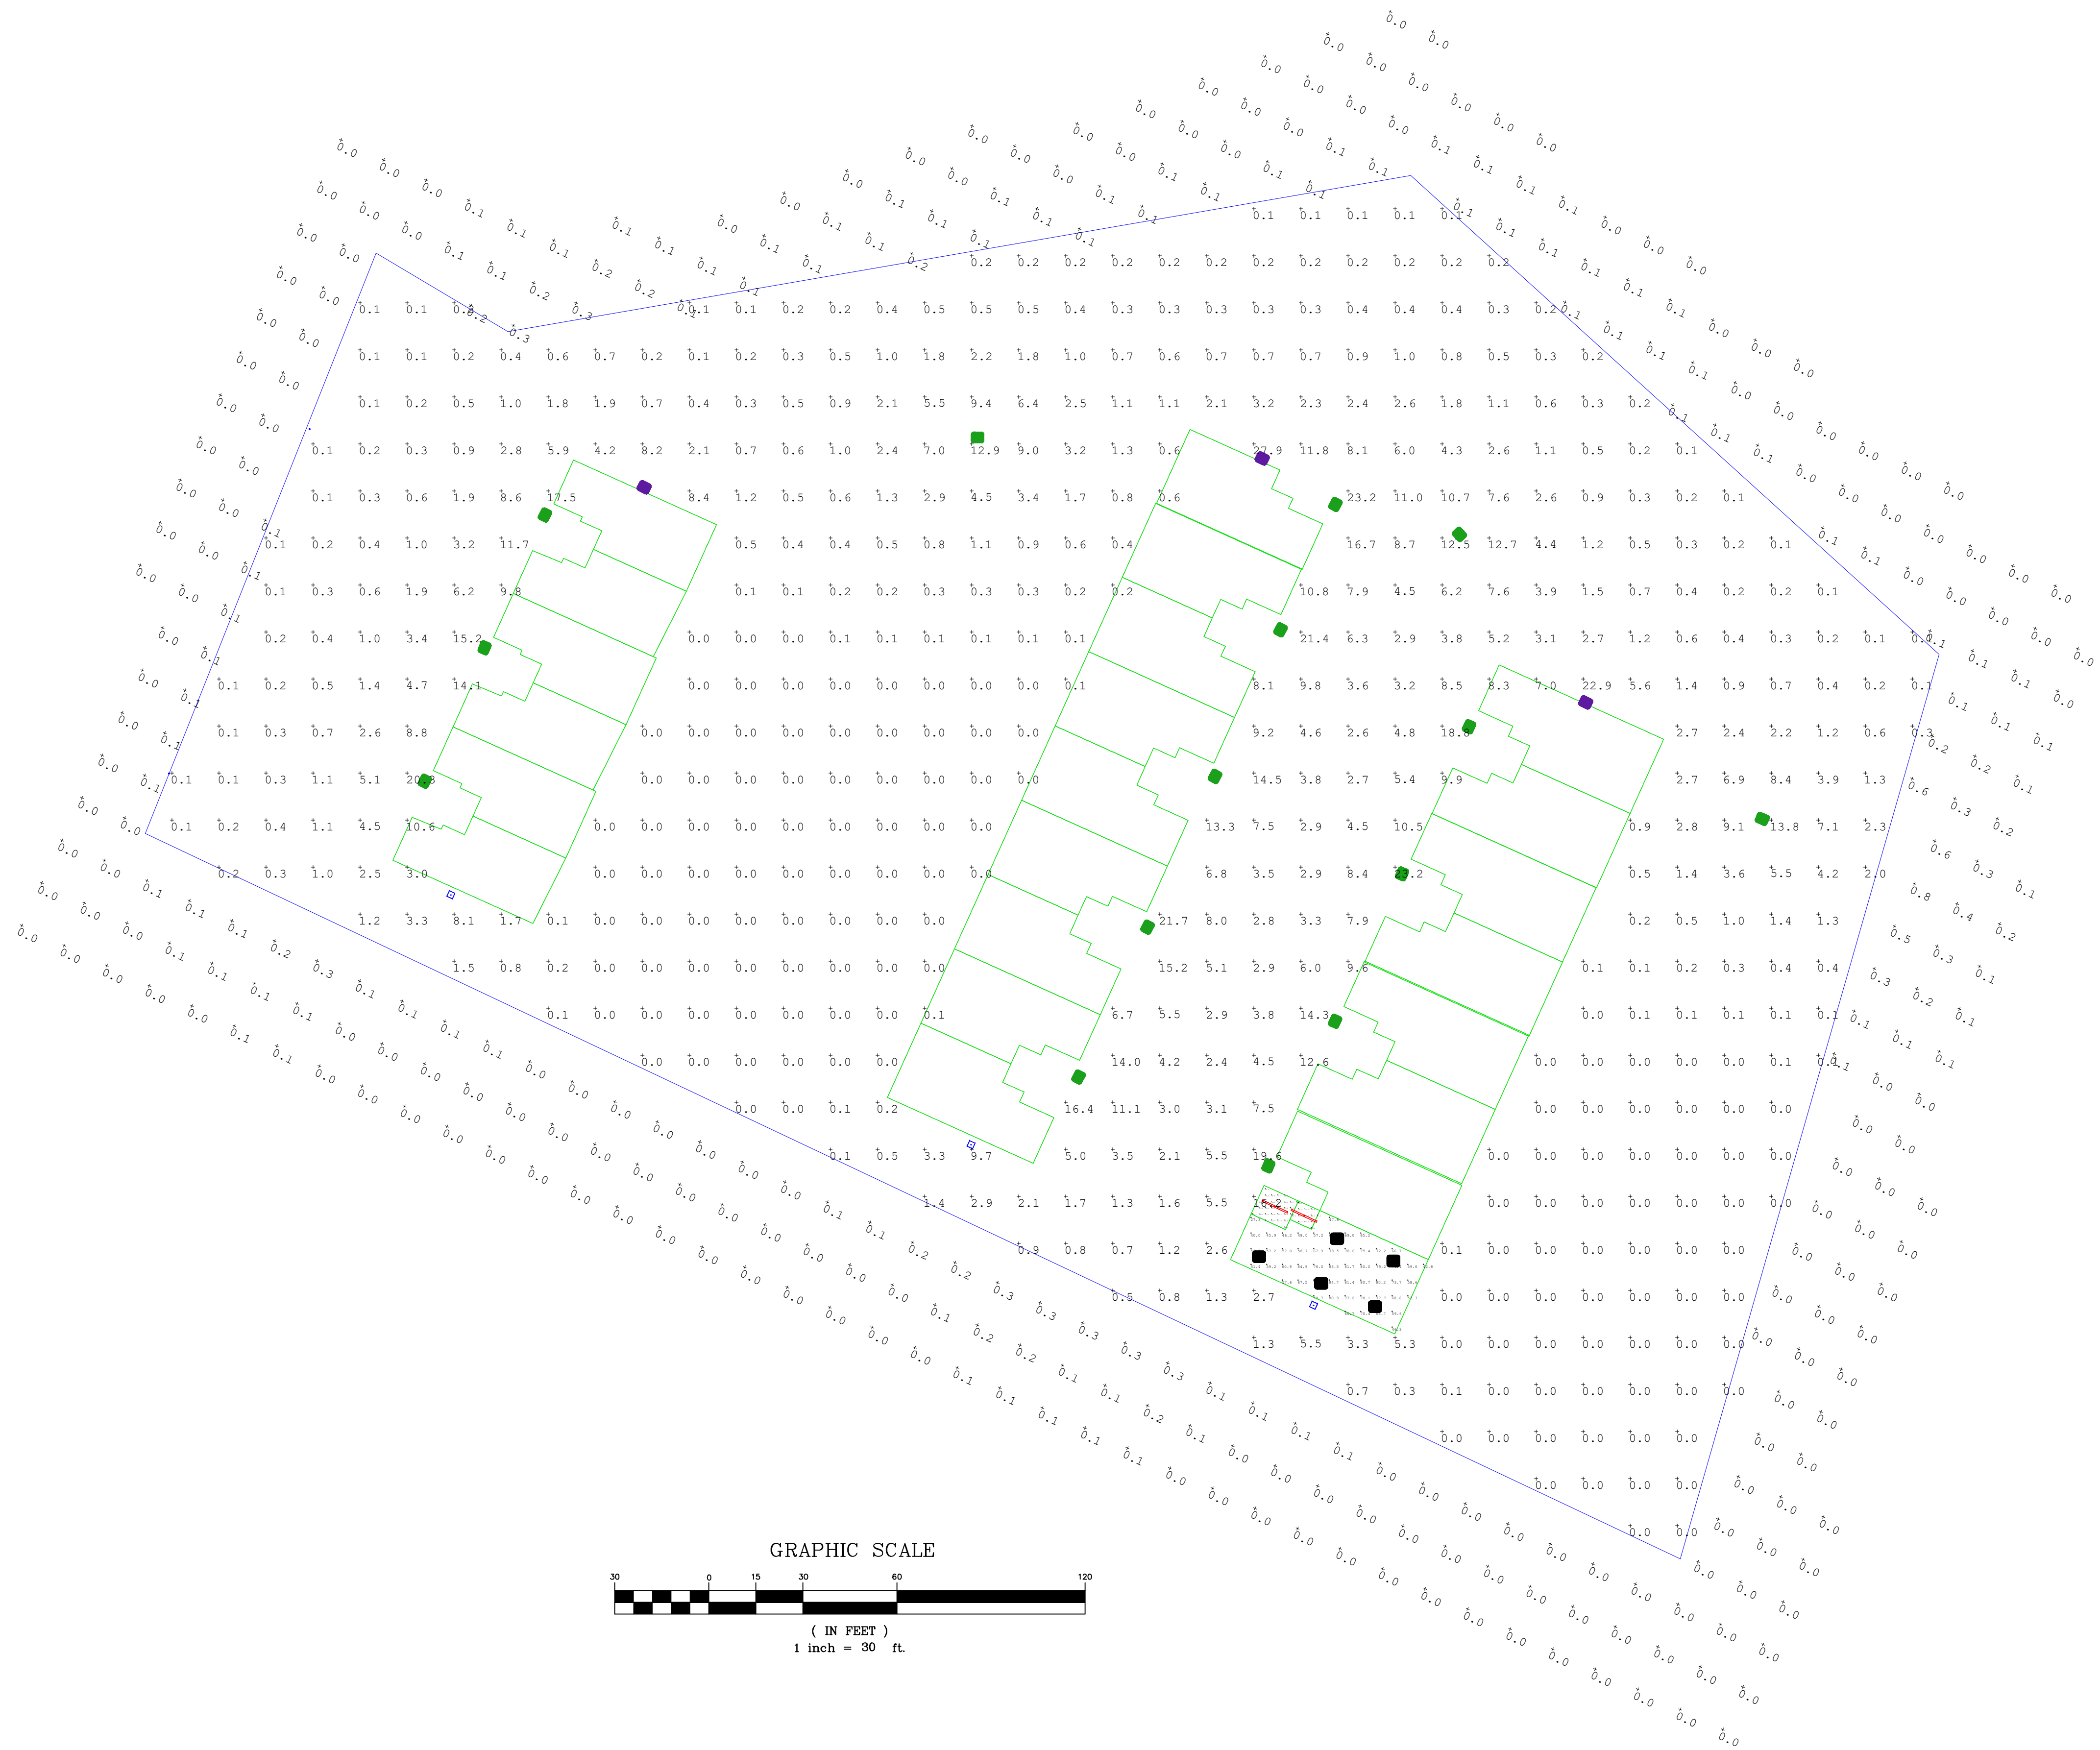


General Notes

UNAUTHORIZED ALTERATIONS OR ADDITIONS TO THIS DRAWING IS A VIOLATION OF SECTION 7209(2) OF NYS EDUCATION LAW.

NOTES:

LIGHTING PLAN PREPARED BY:

MR. JOE HAWKINS
LIGHTING SPECIALIST
LIGHTING SUPPLY
PH: (617) 468-7352

5	FIRE DEPARTMENT COMMENTS	8/28/24
4	TOWN ENGINEER'S COMMENTS	8/3/24
3	REVISED PLANS FROM CONV STORAGE TO FLEX STORAGE	5/18/24
2	REMOVED GAS MAIN FROM PLAN PER CHG&E REQUEST	3/21/24
1	ADDITION OF UTILITIES AND UTILITY NOTES	3/4/24
No.	Revision/Issue	Date

JEFFREY A. ECONOM, P.E.
CONSULTING ENGINEER
48 LOGANBERRY COURT
HOPEWELL JUNCTION, N.Y. 12533
PHONE: (845) 554-8442
EMAIL: jaeconom@optonline.net

PHOTOMETRIC PLAN FOR
OFFICE/WAREHOUSE FACILITY
for
THE TERRA GROUP, LLC
2021-2025 ROUTE 9W
MARLBOROUGH, NY 12542

Project c:\jobs\23-10\ ROUTE 9W SELF STORAGE SITE PLAN.DWG	Sheet
Date 07-24-23	C-5
Scale AS NOTED	